





LEGEND

- DB DISTRIBUTION BOX
- ESB ESB METERBOX
- HEAT PUMP

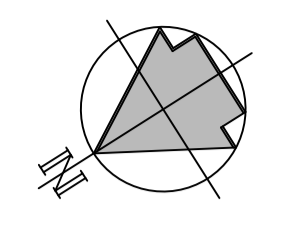

NOTES

- THIS DRAWING SHALL BE READ IN CONJUNCTION WITH ALL OTHER RELEVANT DRAWINGS, SPECIFICATIONS AND SCHEDULES.
- ALL DIMENSIONS ARE IN MILLIMETERS AND LEVELS IN METERS. USE FIGURED DIMENSIONS ONLY.

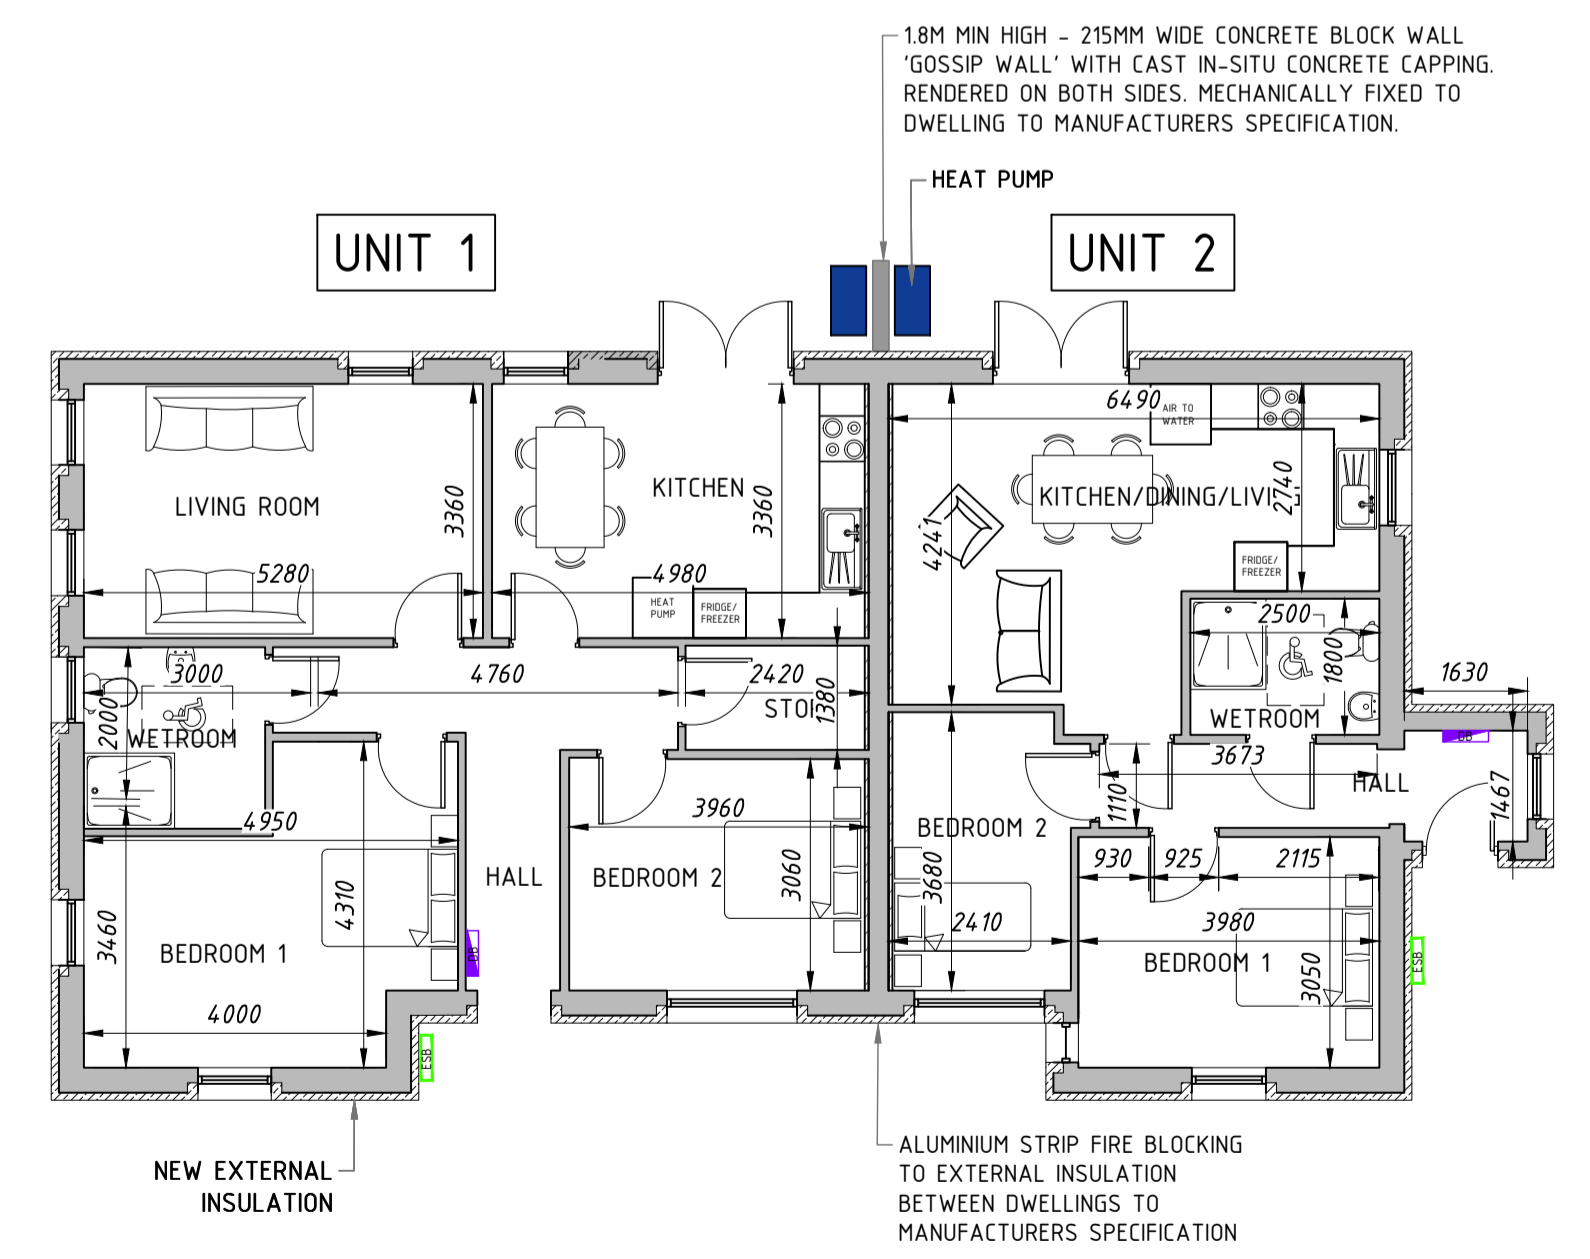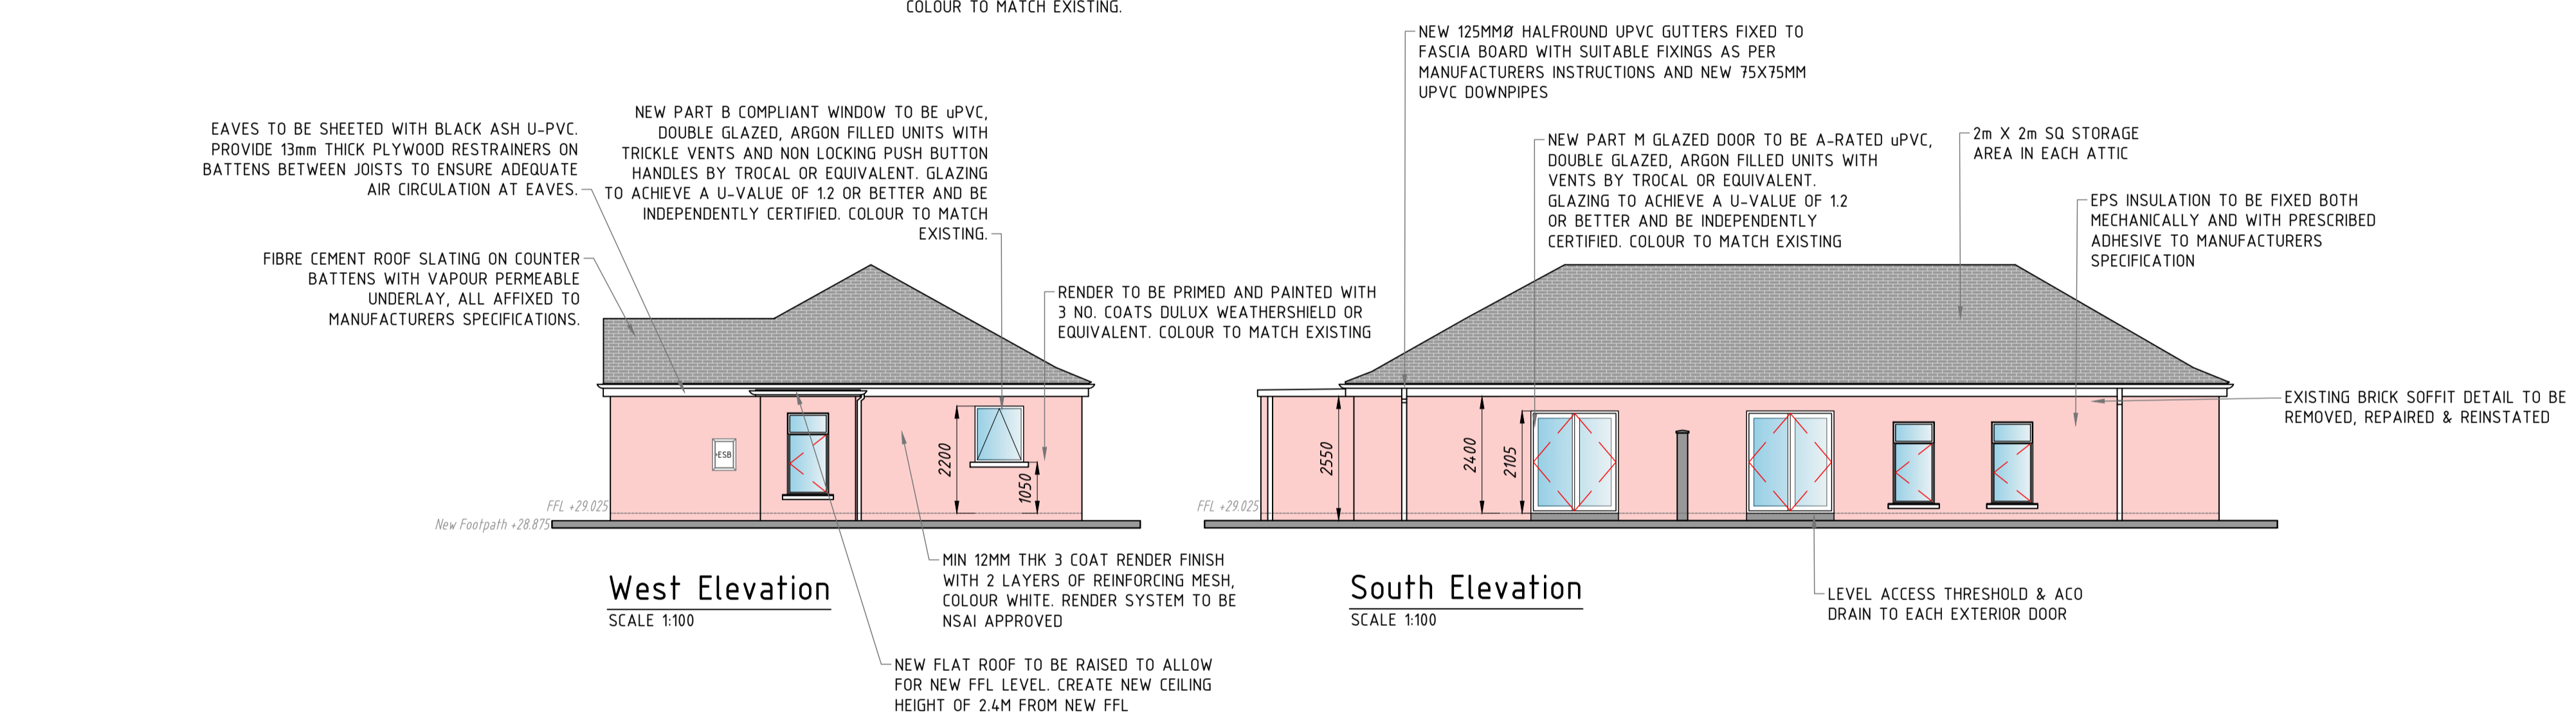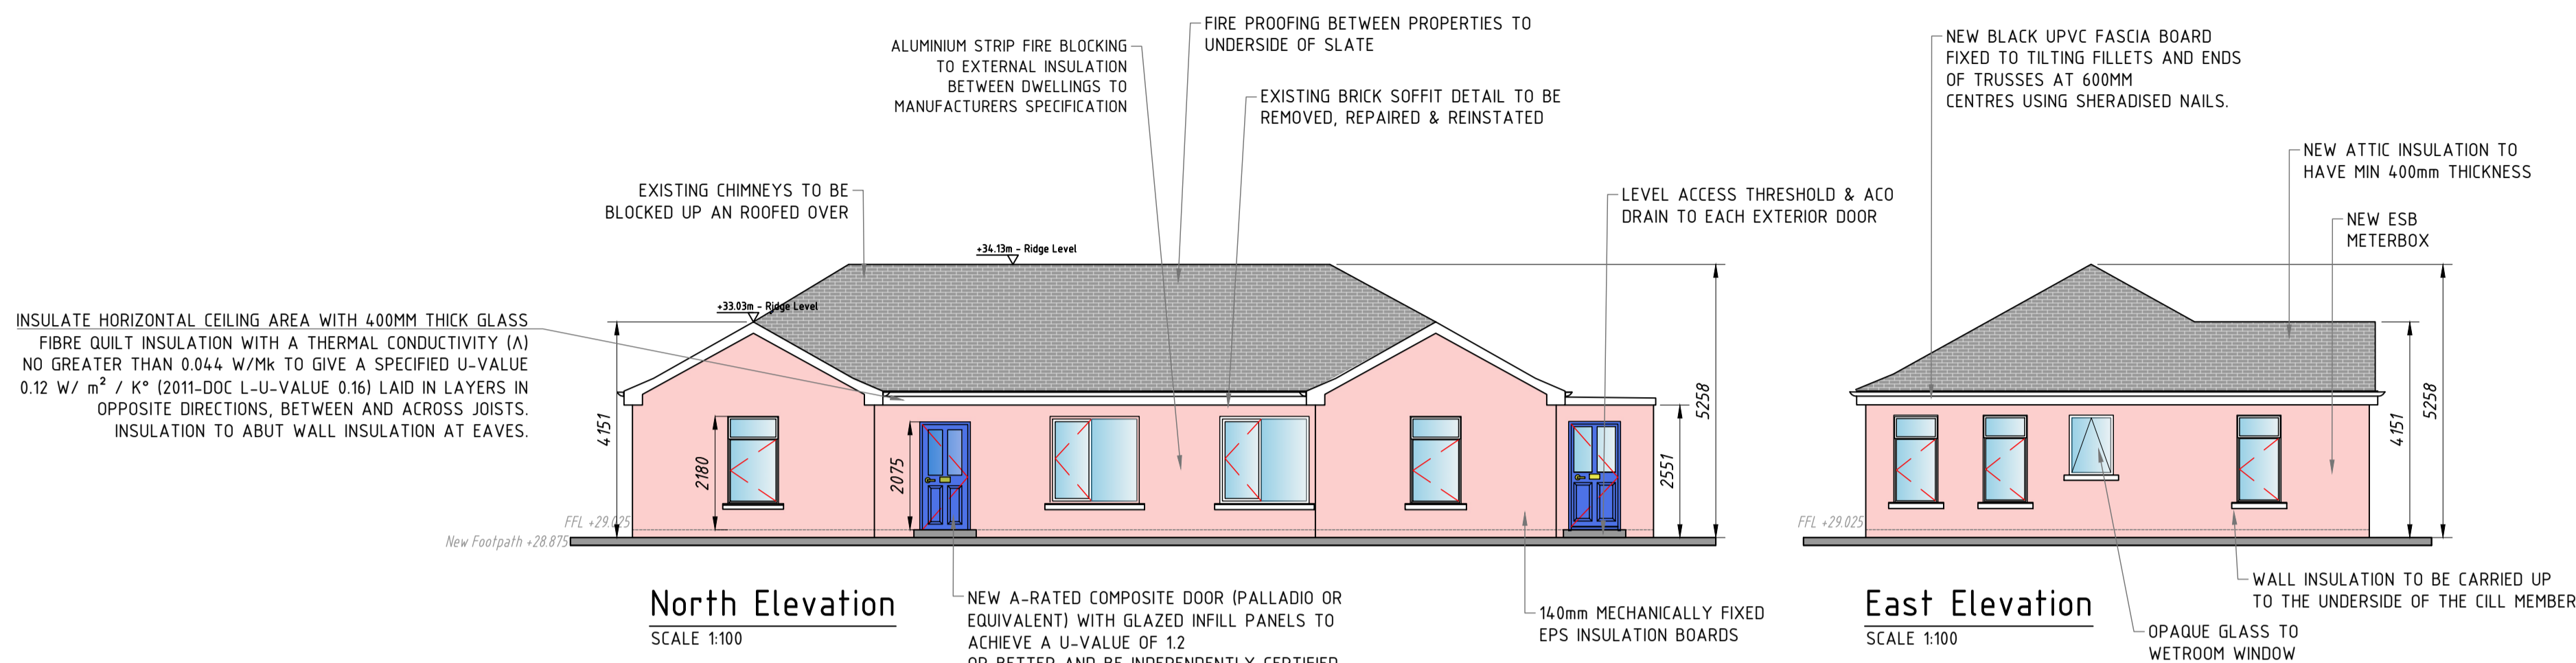

Proposed Ground Floor Plan
SCALE 1:100

THIS DRAWING IS COPYRIGHT © CroCon Engineers Ltd. All rights reserved. No part of this drawing may be reproduced without the prior written permission of CroCon Engineers Ltd. The copyright in this drawing is reserved by CroCon Engineers Ltd. All other rights are reserved.		Drawn By: DOS	Check By: CC	Approved By: CC	Issue Date: 13/03/24	Scale: 1/100 @A1	Project Code: P03	Acceptance Code: S	Rev: 0	Stage: Planning
CROCON ENGINEERS LTD. Consulting Engineers 4 Main St., Bantry, Co. Cork E: info@crocon.ie Tel: (027) 50193		Client: Cork County Council Project: Proposed 2 No. Houses, Goleen Garda Station, Co. Cork Title: Proposed Elevations & Plan								
0	03/24	DOS	Issue 0							